


This plan and design are the property of AMU: Architects and shall remain the property of AMU: Architects. No part of this plan or design may be reproduced without written consent. AMU: Architects shall not be held responsible for any errors or omissions on the part of the contractor or any other party. The contractor shall be responsible for all dimensions and conditions on the job. This office shall be removed of any liability for any errors or omissions on the part of the contractor. These drawings refer only to the project named herein.

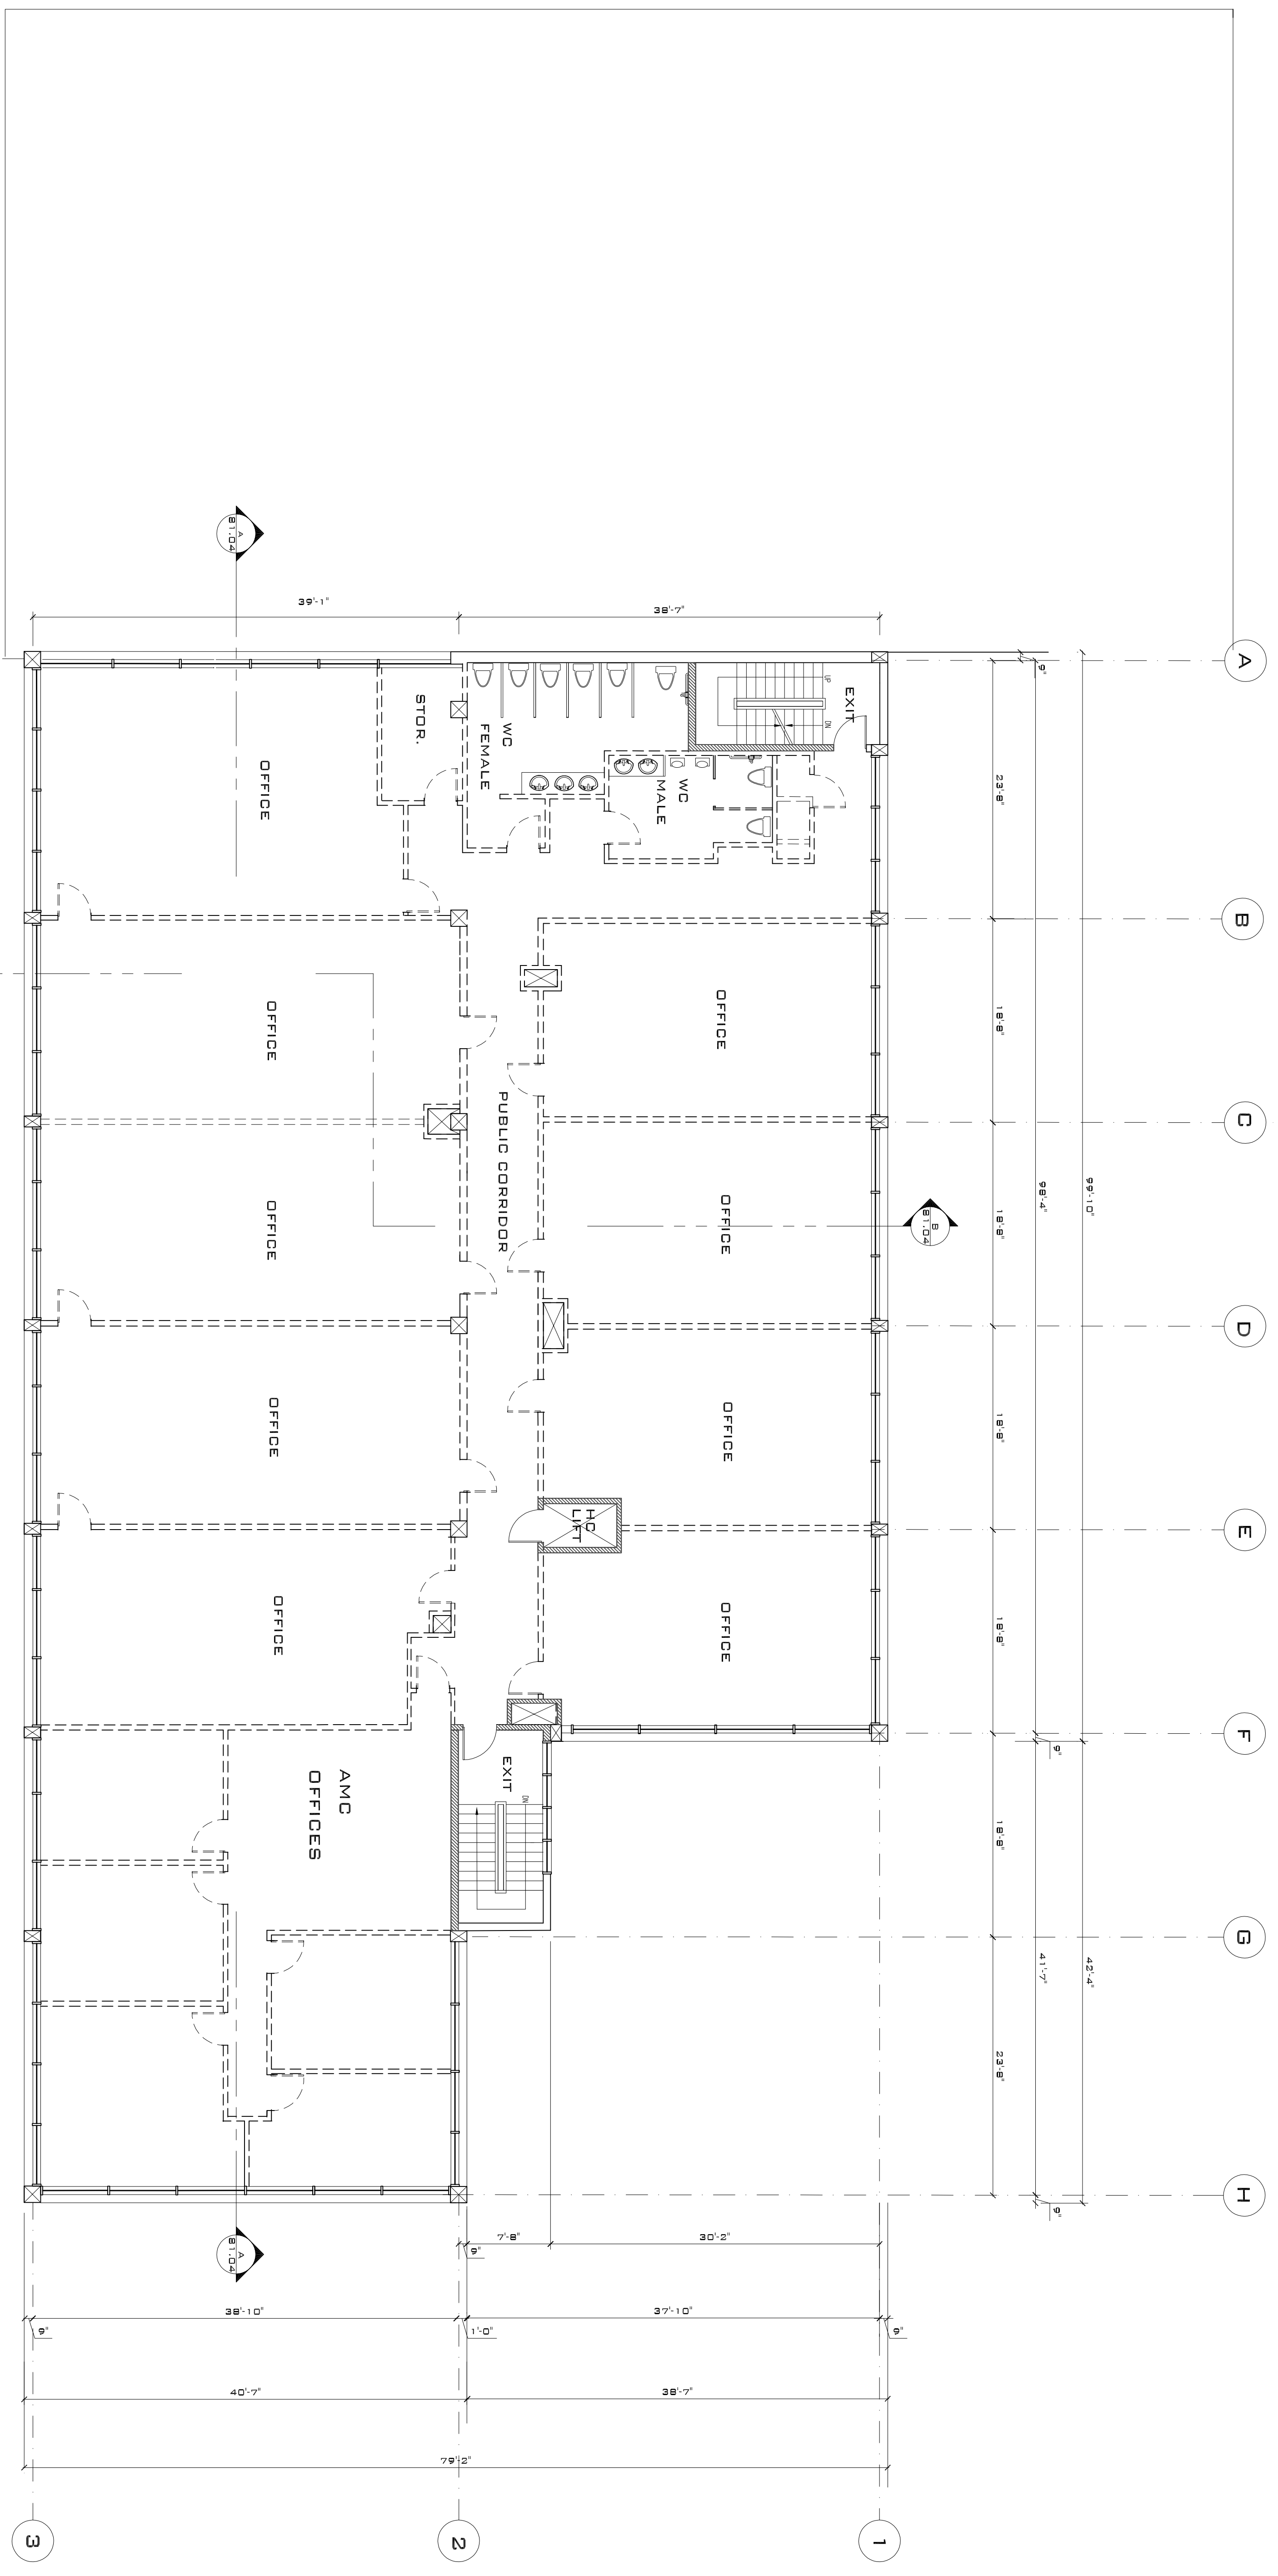

**EXISTING THIRD FLOOR PLAN/
DEMOLITION PLAN 1/8" = 1'-0"**

INTERIOR WALLS TO REMAIN

 INTERIOR WALLS TO BE DEMOLISHED AND REMOVED

 DOORS TO BE DEMOLISHED

 ALL THIRD FLOOR PLUMBING FIXTURES TO BE REMOVED

rev.	date	description	by
01	15. JAN. 08	PRELIMINARY	---
02	21. FEB. 08	REV. HOUSING PLAN	---
03	31. MAR. 08	CONSULTANTS	---
04	25. MAR. 08	REV. HOUSING PLAN	---
05	03. MAR. 09	RE-SSUE FOR TENDER	---

AMU: Architects

PETER WOLFF PARTNERSHIP
 ARCHITECTS
 2288 WEST 27 AVENUE
 VANCOUVER BC V6M 1P1
 TEL: 604 677 4838
 FAX: 604 677 4836
 EMAIL: AMU@TELUS.NET

designer	date	JAN. 2008
drawn by	scale	---
checked by	Project No.	0701
digital	File No.	---

Project Name
AMC TRANSITION HOUSING
2018 DUNDAS ST.
VANCOUVER, B.C.

Drawing Title
THIRD-FLOOR PLAN
EXISTING
DEMOLITION PLAN